

**KUNCHAL RESIDENCE**  
LANDSCAPE LIGHTING LAYOUT  
LIGHTING ANALYSIS

U1 / FL2




P3



**LUMINAIRE SCHEDULE**

Symbol	Label	Qty	Catalog Number	Description	Lamp
	U1	12	LV123 OR EQUAL HANOVER LANTERN	H.GRAZE LIGHT	MR11
	FL2A	7	LV123 OR EQUAL HANOVER LANTERN	FLOOD/POST	MR11
	FL2B	36	LV123 OR EQUAL HANOVER LANTERN	FLOOD/TREE	MR11
	P3	21	LVW134 OR EQUAL HANOVER LANTERN	PATH LIGHT	18WATT MR11
	ST4	29	LVW137 OR EQUAL HANOVER LANTERN	STEPLIGHT	9WATT HALOGEN
	FL5	3	LV121 OR EQUAL HANOVER LANTERN	LOW-LEVEL FLOOD LIGHT	20WATT MR16
	altIG	5	#WM7A/M03/25 VISION3 LIGHTING	***ALTERNATE*** UPLIGHT/DOWNLIGHT WALL-MOUNT	PAR 20 HALOGEN
	M1	2	8778 BEGA LIGHTING	60-DEGREE LOUVERED IN-GRADE MARKER LIGHT	(1) 20W T3 G4/12V MH
	M2	2	8774 BEGA LIGHTING	180-DEGREE LOUVERED IN-GRADE MARKER LIGHT	(1) 20W T3 G4/12V MH

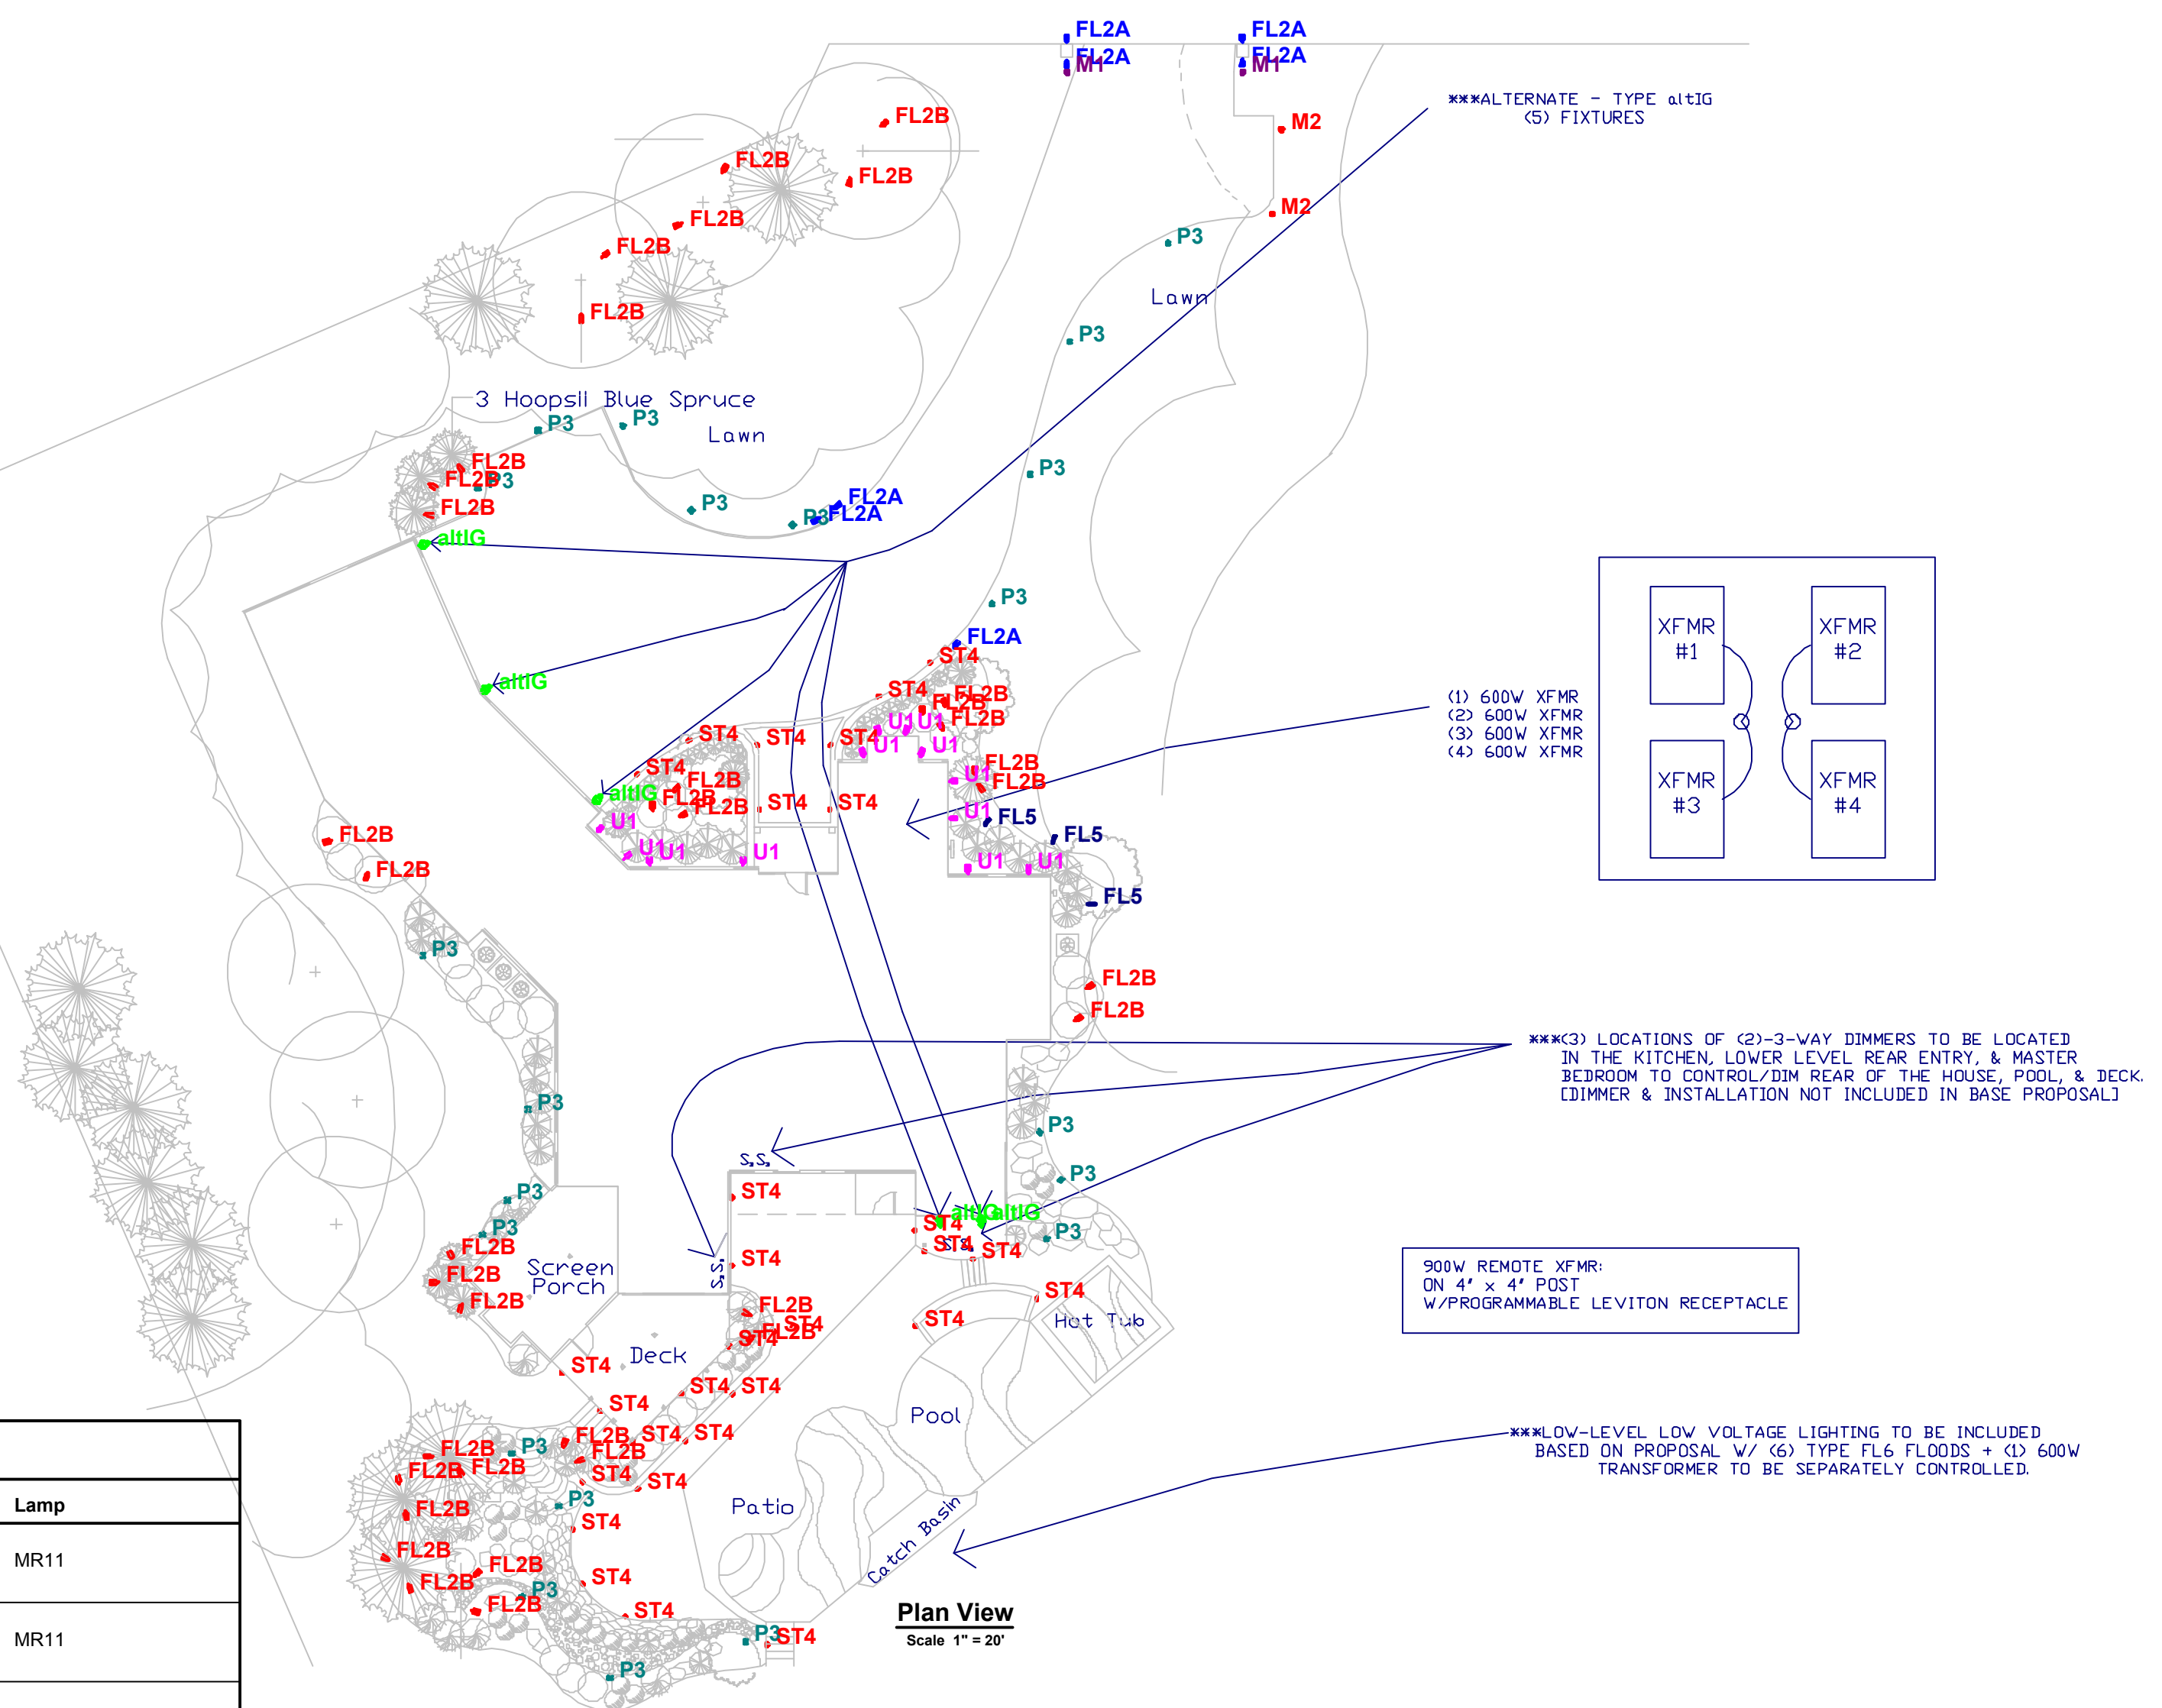

ST4



FL5



IG (alt)



**For Review:**

Date  
Oct 19 2006

Scale  
as noted

Drawing No.