


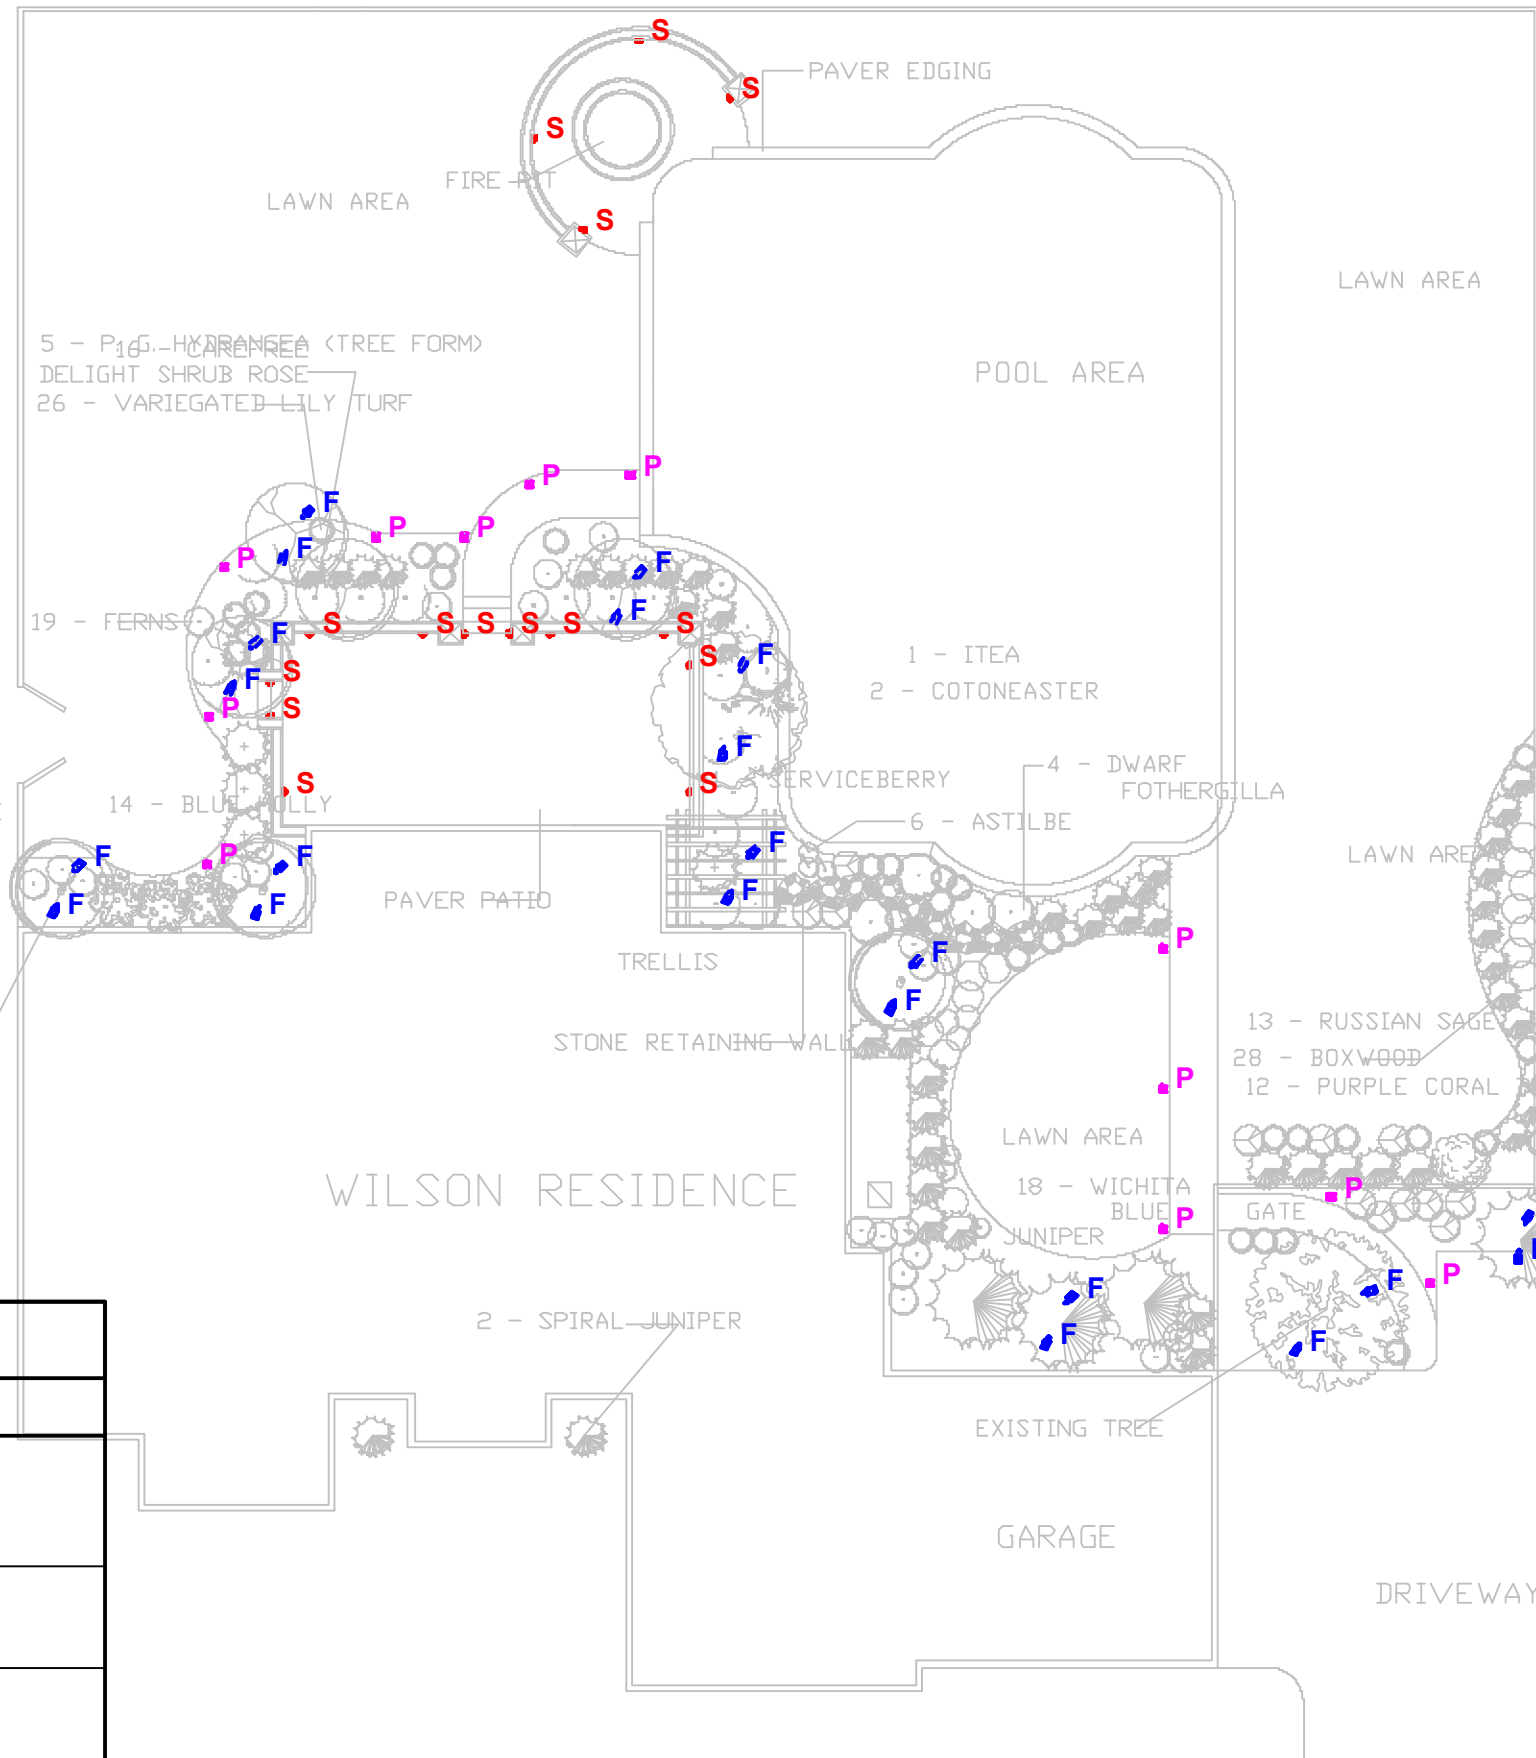

**WILSON RESIDENCE**  
Landscape Lighting Layout



LUMINAIRE SCHEDULE					
Symbol	Label	Qty	Catalog Number	Description	Lamp
	P	12	LWV134 OR EQUAL HANOVER LANTERN	PATH LIGHT	18WATT
	F	22	LV123 OR EQUAL HANOVER LANTERN	SPOTLIGHT/FLOODLIGHT 35WATT MR16	
	S	15	LWV137 OR EQUAL HANOVER LANTERN	STEPLIGHT	9WATT

**Entire Plan**  
Scale 1" = 16'

**For Review:**  
review

**Date**  
Sept. 19, 2006

**Scale**  
as noted

**Drawing No.**